



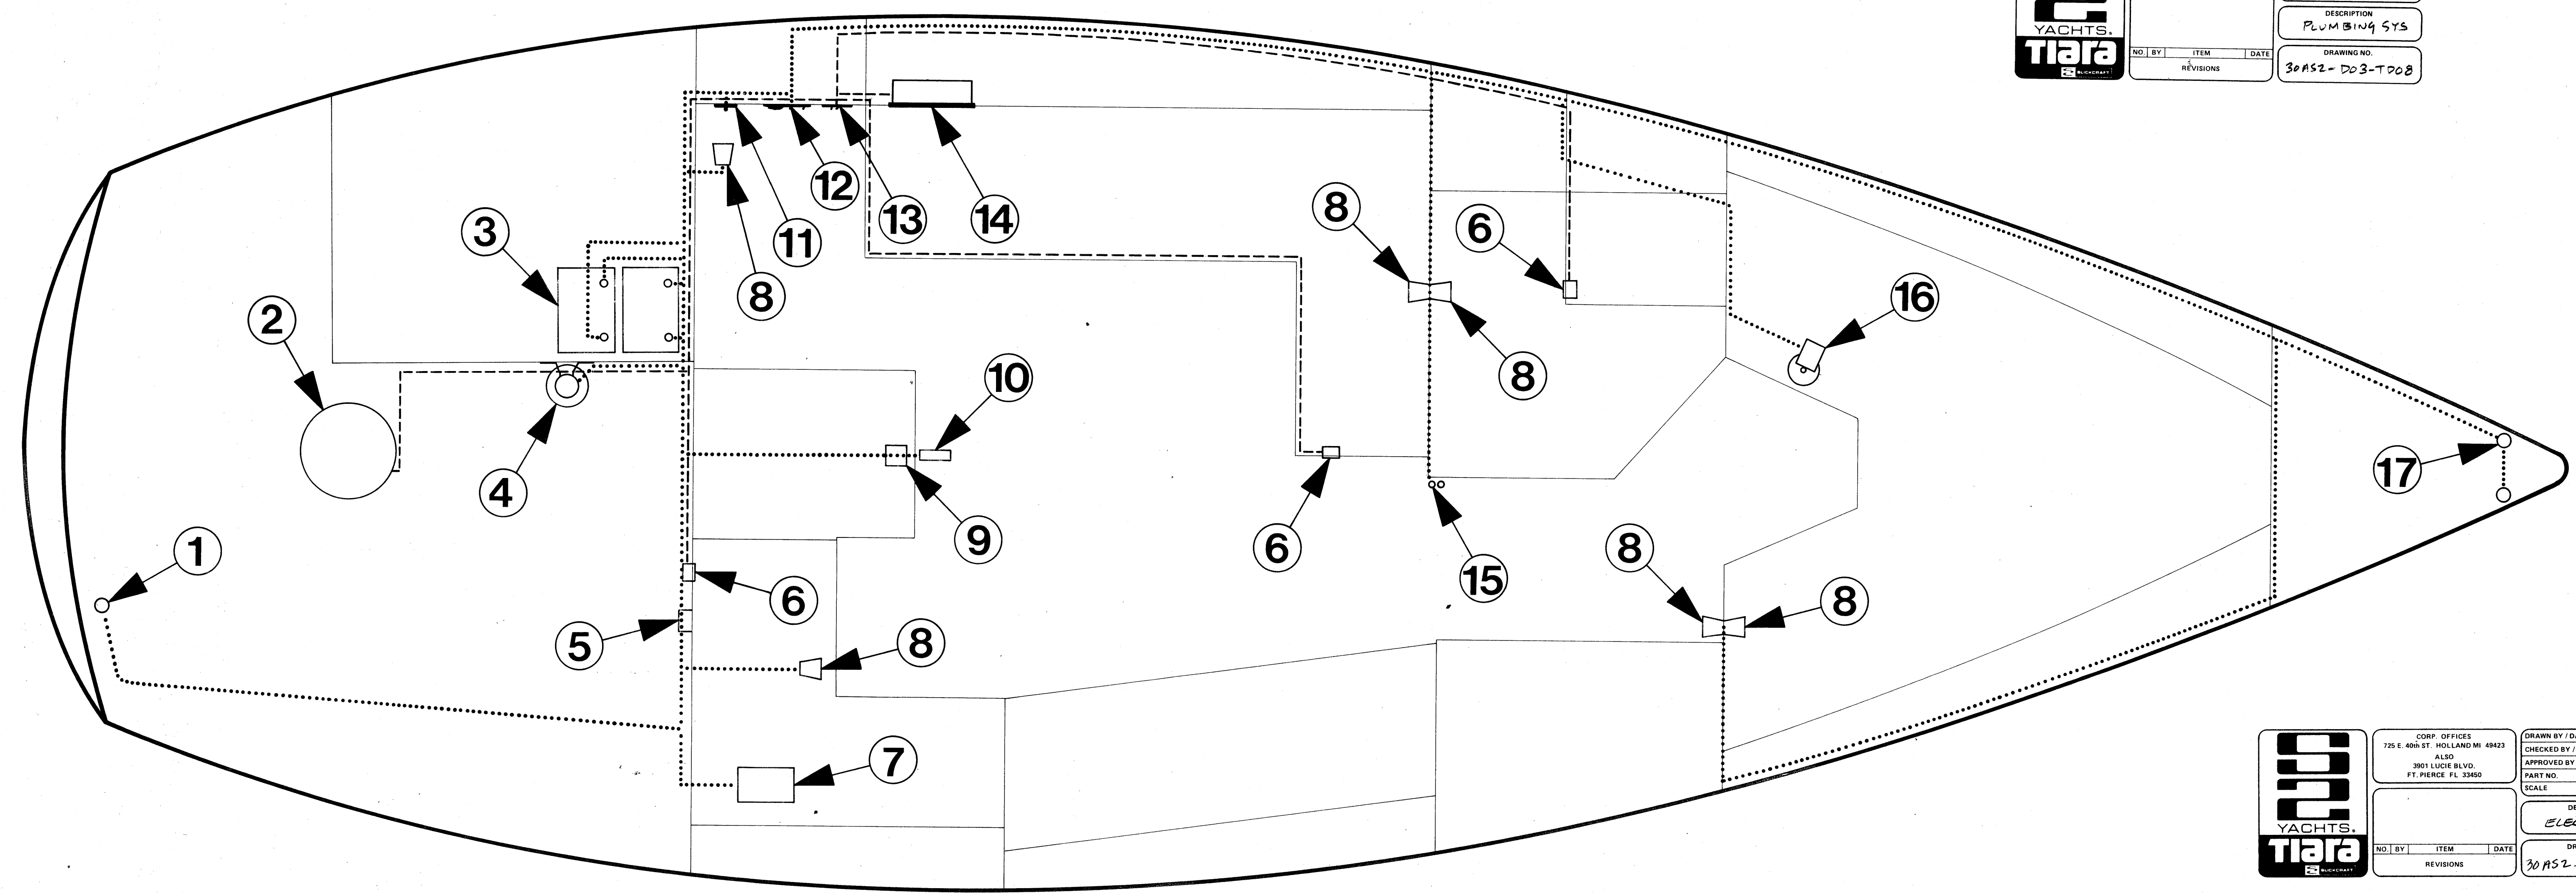
COMP + SWIM POOL PLUMBING

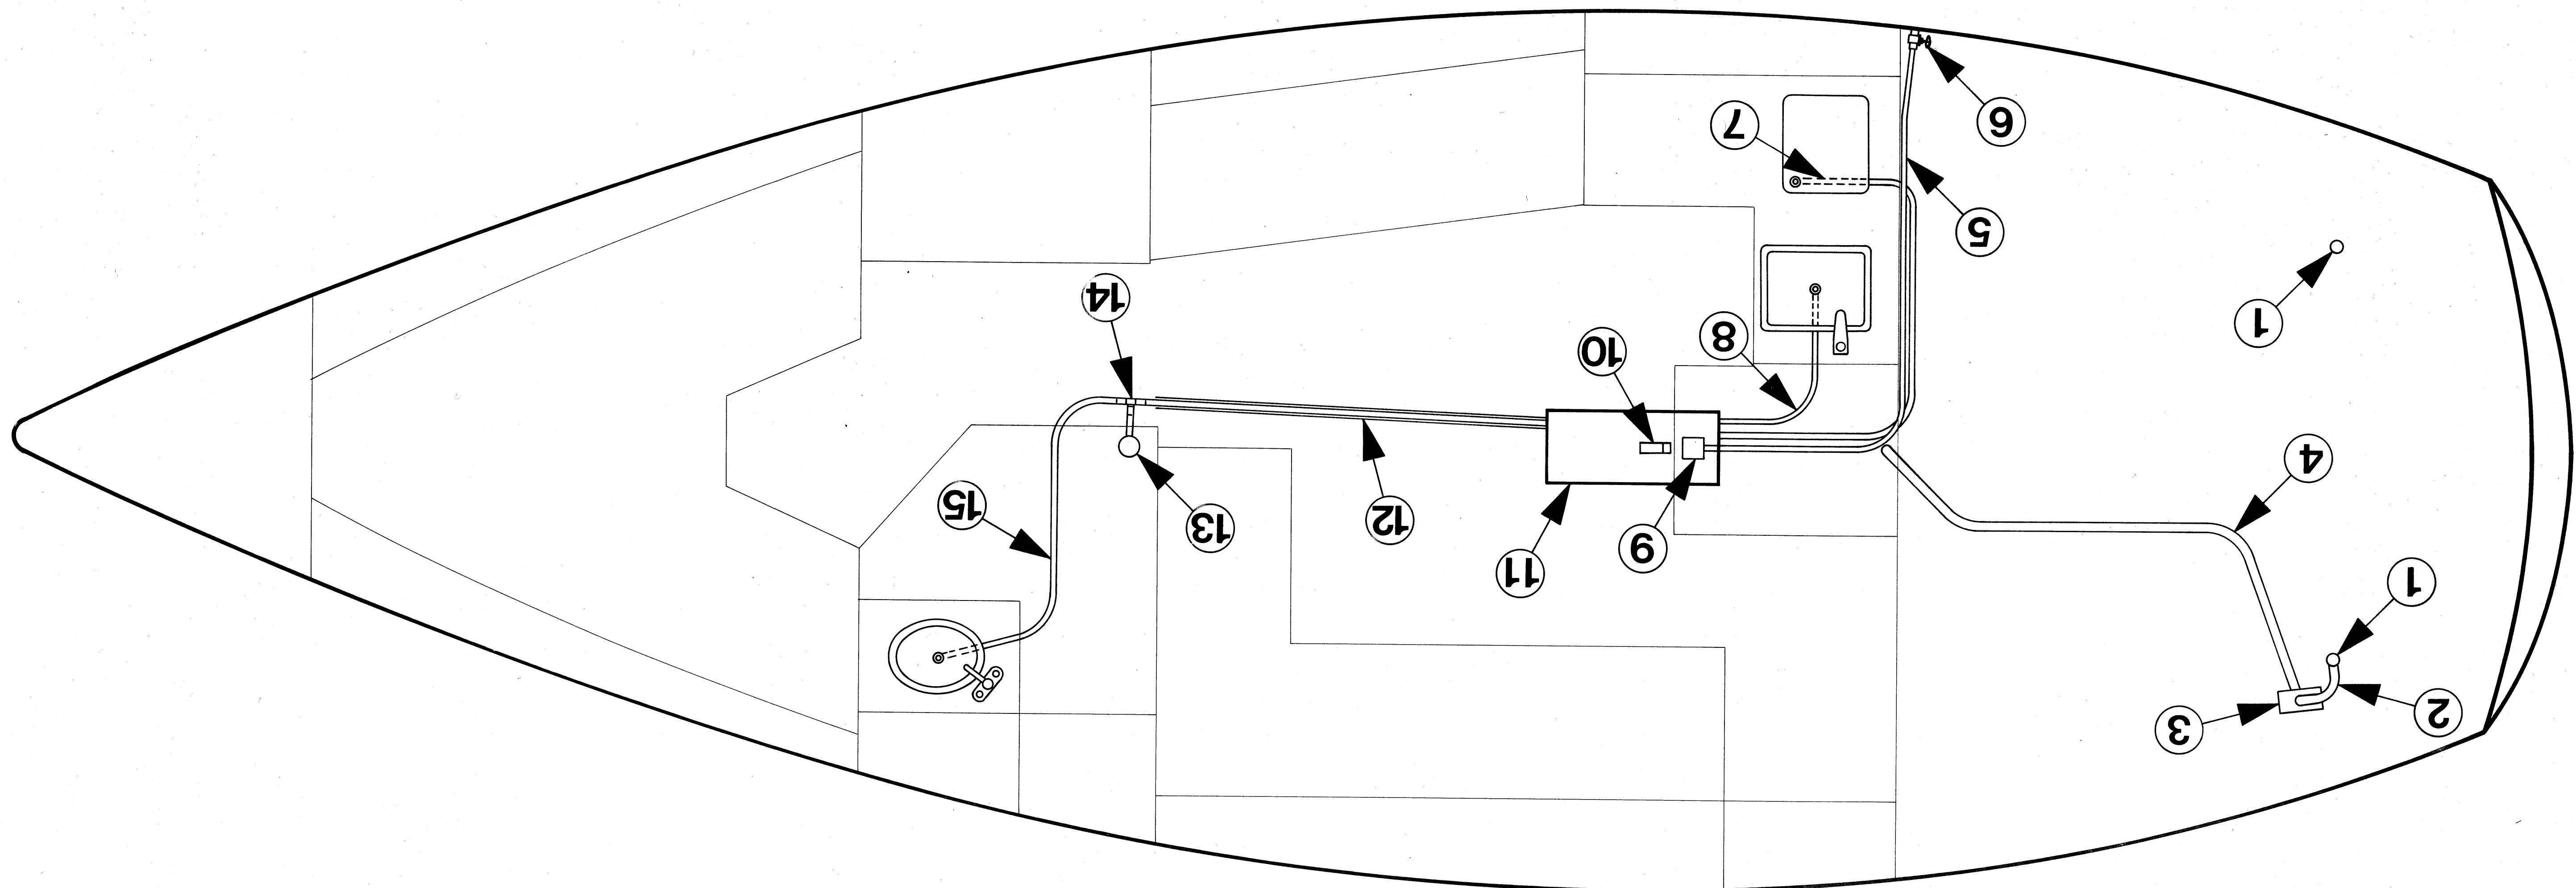




CORP. OFFICES
725 E. 40th ST. HOLLAND MI 49423
ALSO
3801 LUCIE BLVD.
FT. PIERCE FL 33450

DRAWN BY / DATE	
CHECKED BY / DATE	
APPROVED BY / DATE	
PART NO.	
SCALE	TOL.
DESCRIPTION PLUMBING SYS	
DRAWING NO. 30A52-DD3-TD08	





CORP. OFFICES
725 E. 40th ST. HOLLAND MI 49423
ALSO
3801 LUCIE BLVD.
FT. PIERCE FL 33450

DRAWN BY / DATE	
CHECKED BY / DATE	
APPROVED BY / DATE	
PART NO.	
SCALE	TOL.
DESCRIPTION ELECTRICAL LAYOUT	
DRAWING NO. 30A52-C01-TD08	

23.10.16